


LEGEND		LEGEND	
SYMBOL	DESCRIPTION	SYMBOL	DESCRIPTION
---	GABLE VENT	⊕	ELECTRICAL OUTLET
---	EXTERIOR WALL LIGHTS	⊕	WATER HEATER
---	INTERIOR WALL LIGHTS	⊕	
---	INTERIOR CEILING LIGHTS	⊕	
⊕	FLOOR DRAIN	⊕	


### WALL TYPE SCHEDULE

8" REINFORCED CONCRETE MASONRY  
BLOCK WALL WITH MORTAR JOINTS,  
GROUTED SOLID ALL CELLS RUNNING  
BOND PATTERN.

THESE PLAN VIEW AND ELEVATION DRAWINGS ARE A  
PRELIMINARY ARCHITECTURAL REPRESENTATION OF  
THE BUILDING. ALL DIMENSIONS, FEATURES AND  
COMPONENTS SHOWN ON THESE PRELIMINARY  
DRAWINGS MAY OR MAY NOT BE PART OF THE  
QUOTE.

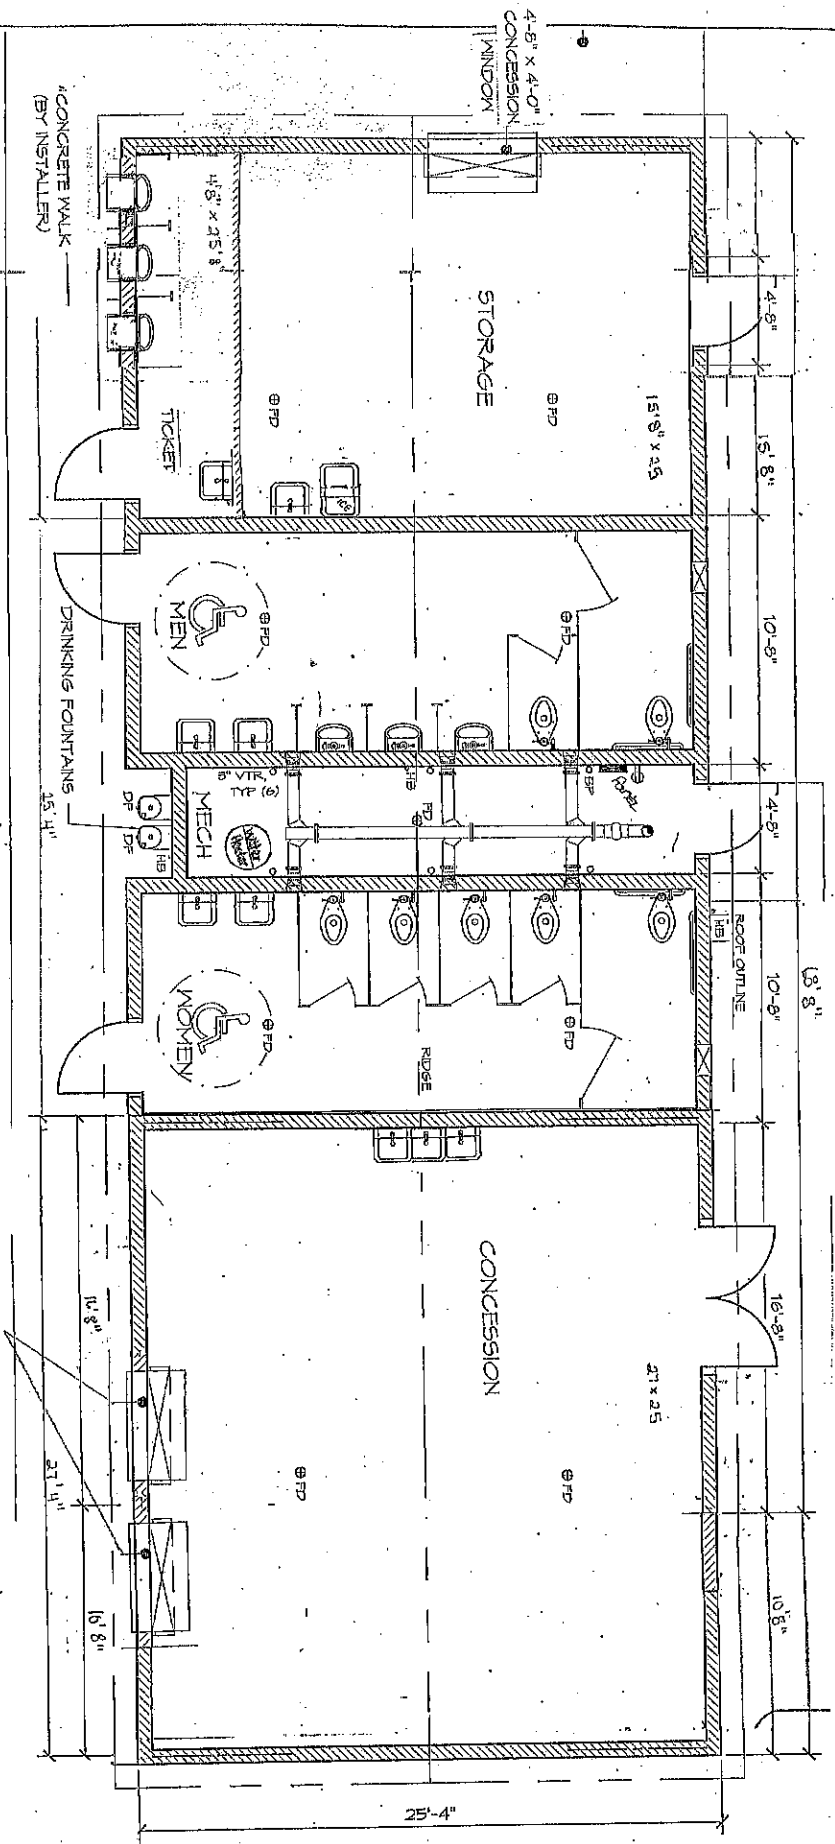

1 FLOOR PLAN  
SCALE

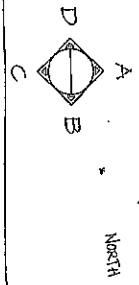

PROJECT: MULTI-USER RESTROOM W/ CONCESSION & STORAGE  
 PROJECT: CUSTOMER PROJECT LOCATION  
 SHEET TITLE: FLOOR PLAN

NO.	DATE	REVISIONS

PROJECTOR: \_\_\_\_\_  
 WORKER: \_\_\_\_\_  
 DATE: \_\_\_\_\_

DRAWN BY: \_\_\_\_\_  
 SHEET NO. 1

PRELIMINARY